

ELECTRICAL SCHEDULE

3" GLOBE BALL BROT

HALOGEN PUCK LIGHT

POT LIGHT

CEILING FAN

BATH/WALL LIGHT

CEILING LIGHT

CHANDELLER

FLOURESCENT FIXTURE

WALL MOUNT MOTION LIGHT

120 VOLT SMOKE DETECTOR INTERCONNECTED

SWITCH

3 WAY SWITCH





RECEPTICLE

G.F.I. PROTECTED OUTLET

120 VOLT OUTLET

NOTE:
ALL ELECTRICAL TO CONFORM TO CODE
AND TO CONTRACTOR'S REQUIREMENTS

ELECTRICAL PLAN
3/16" = 1'-0"

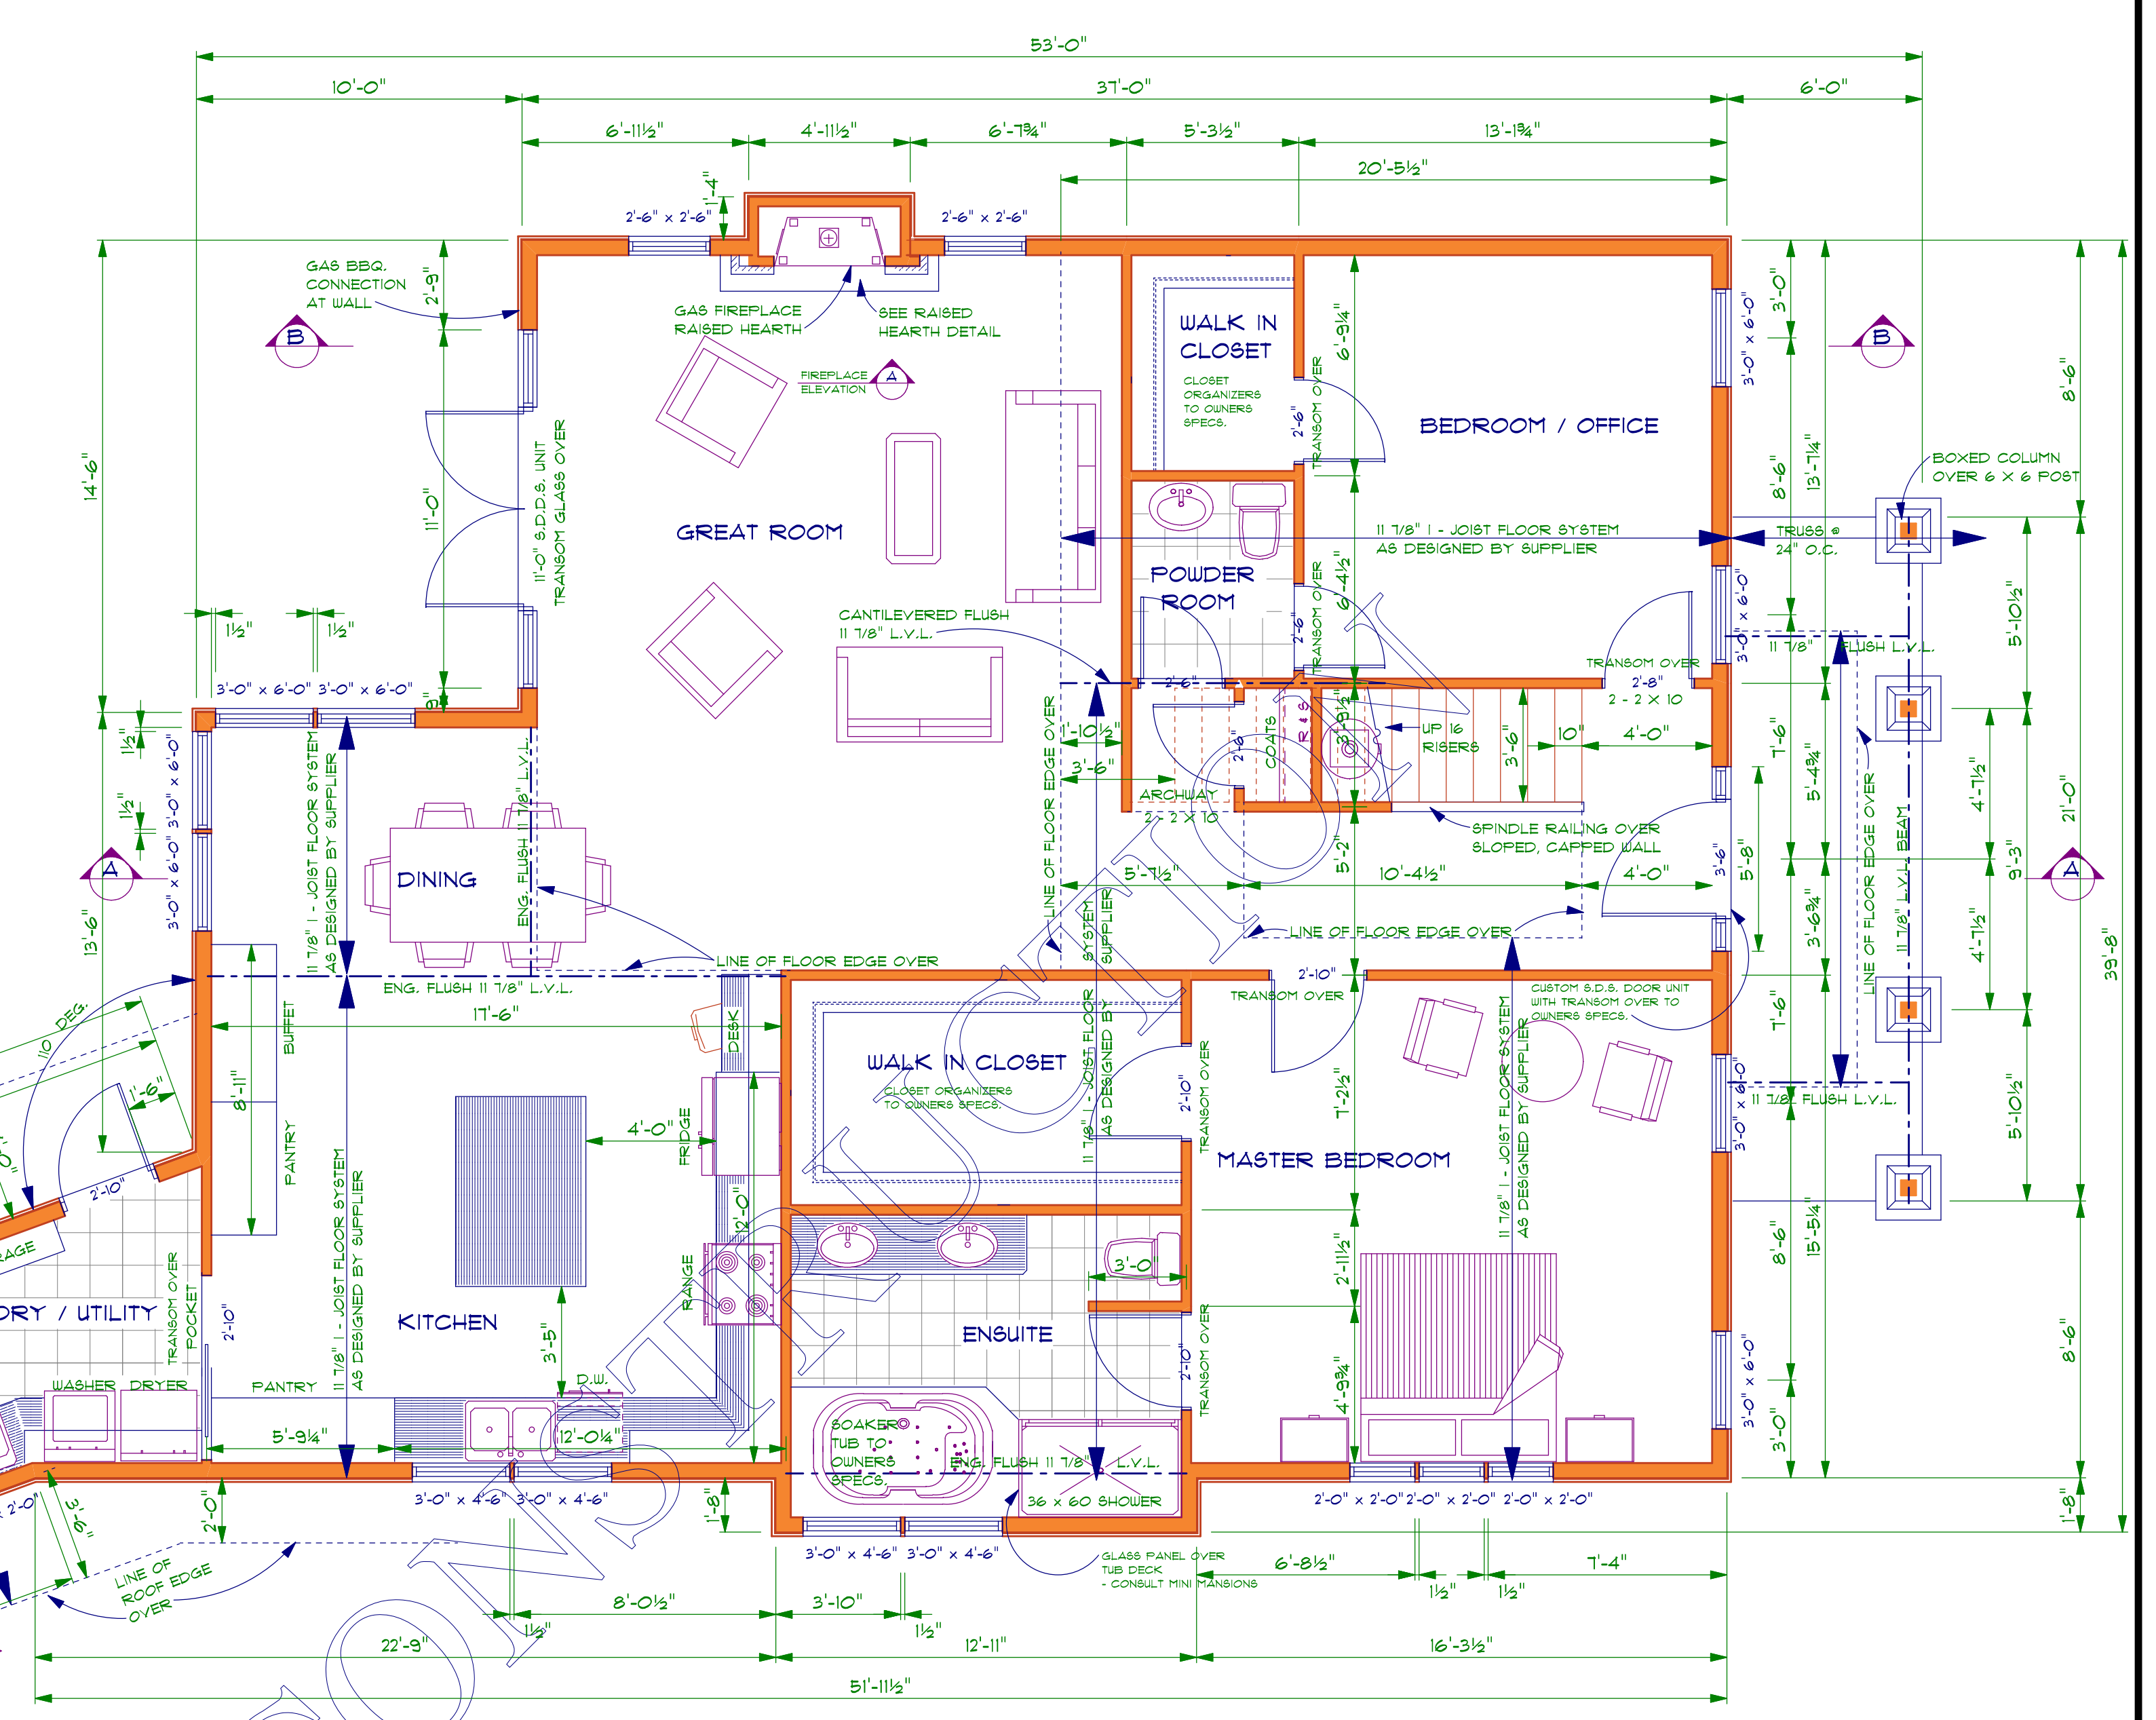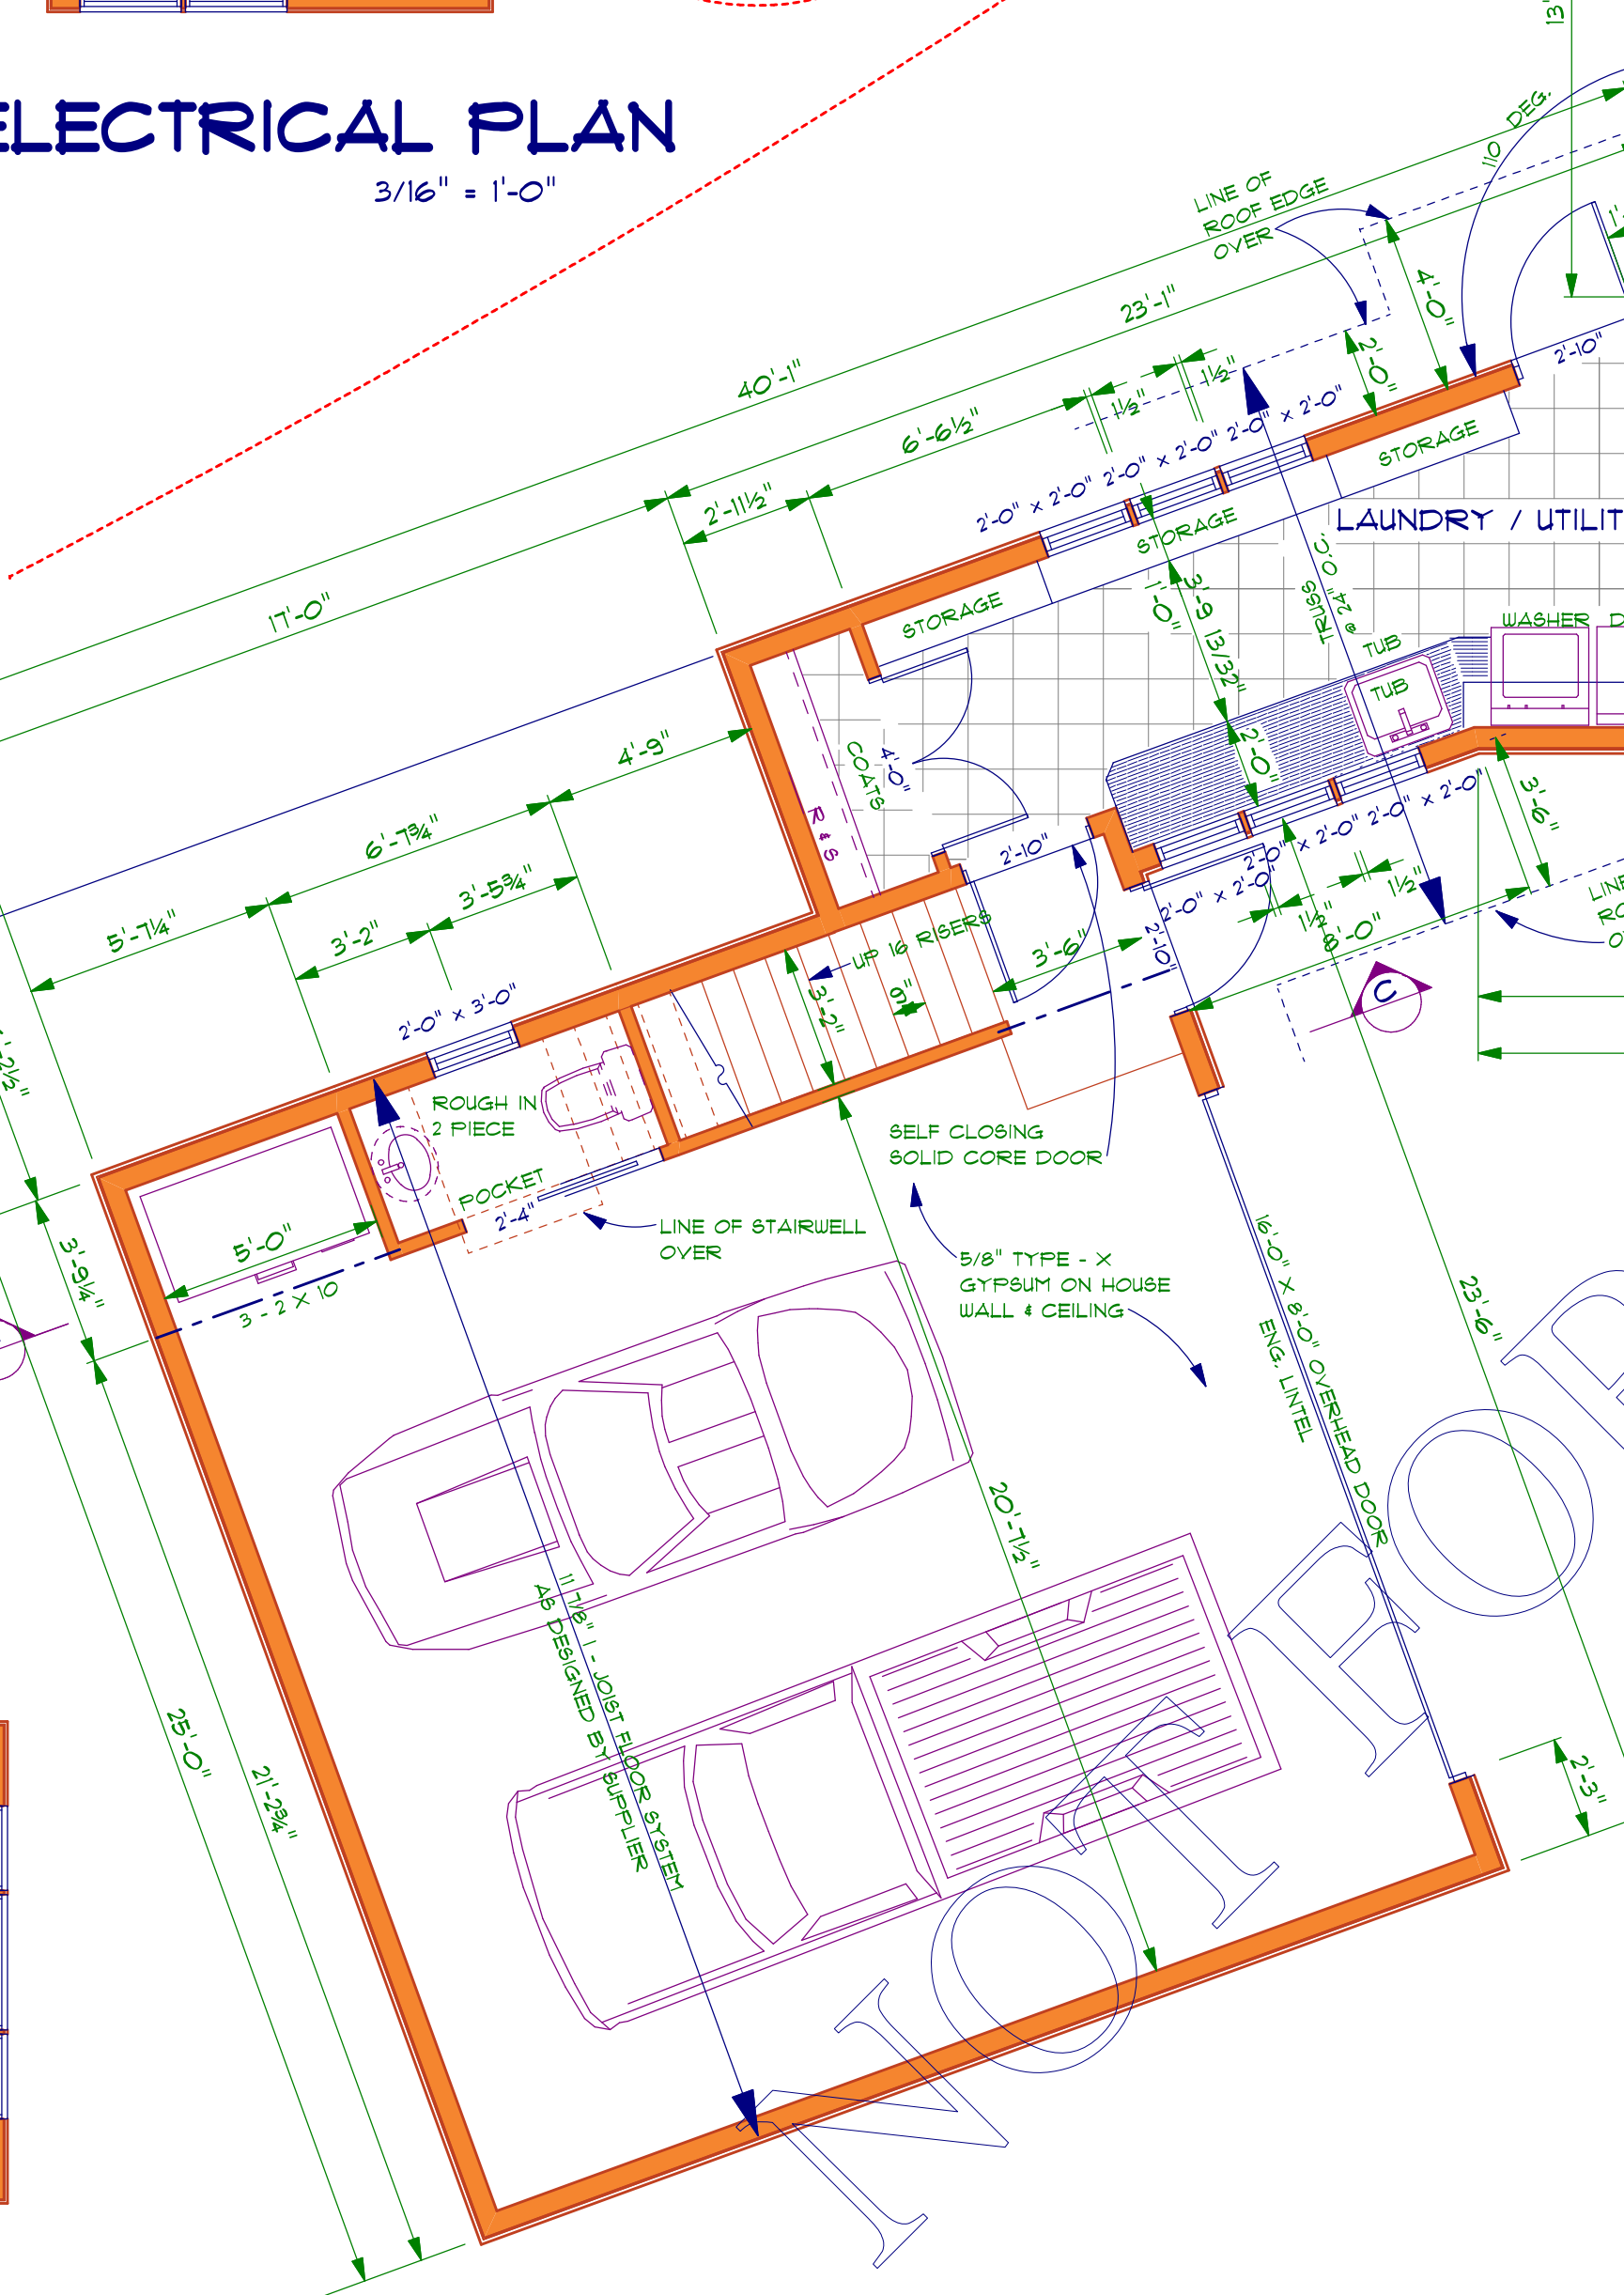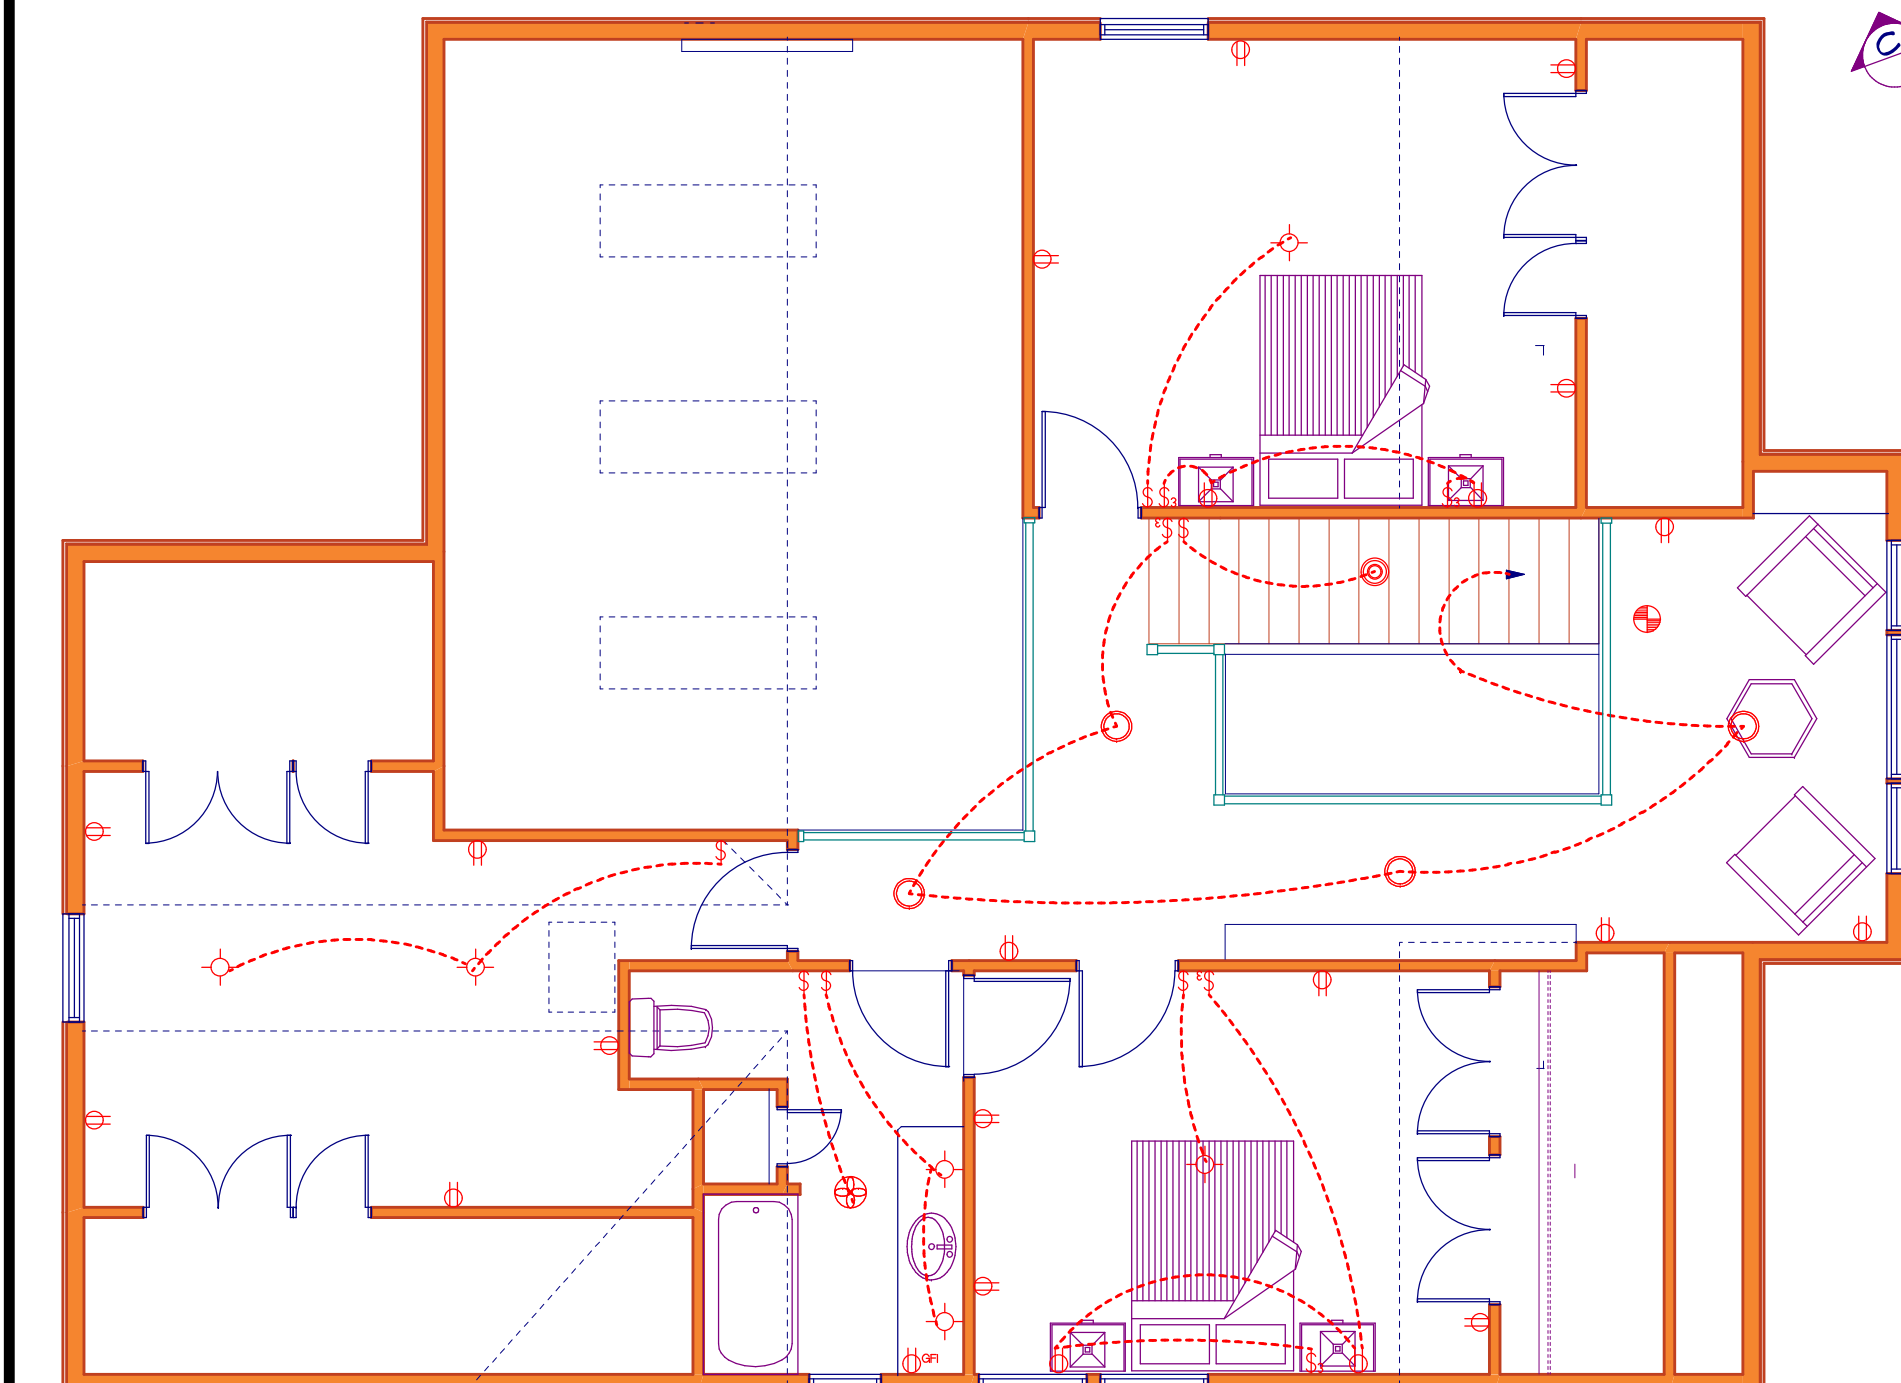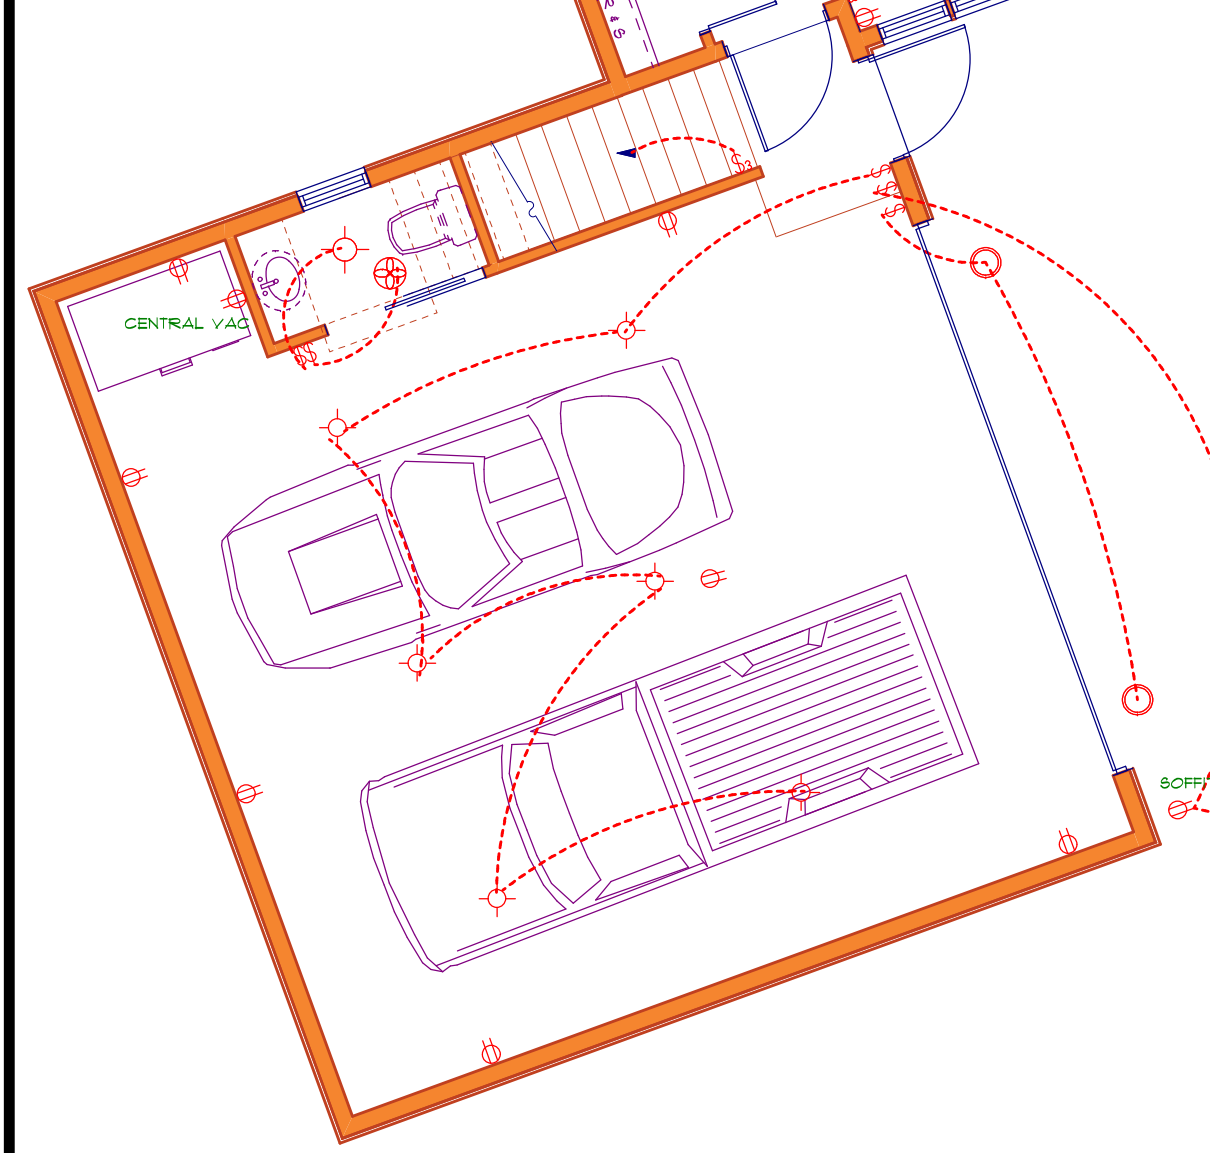


MAIN FLOOR PLAN

1839 SQ. FT.
25% LOT COVERAGE ALLOWABLE = 2599.6 SQ. FT.
LOT COVERAGE AS SHOWN = 2558 SQ. FT.

DIMENSION NOTE:
- EXTERIOR WALL DIMENSIONS ARE TO OUTSIDE OF WALL SHEATHING (ASSUMING A TOTAL OF 6" WIDTH)
- INTERIOR WALL DIMENSIONS ARE TO CENTRE OF STUD, (ASSUMING 3 1/2" WIDTH)

TYPICAL ROUGH OPENING DIMENSIONS
ALL INTERNAL DOOR R.O.'S TO BE FRAMED 2 1/2" WIDER THAN FINISHED SIZES
CLOSET HEIGHT R.O. TO BE 98 1/2"
INTERIOR DOOR WITH TRANSOM R.O. HEIGHT TO BE 95"

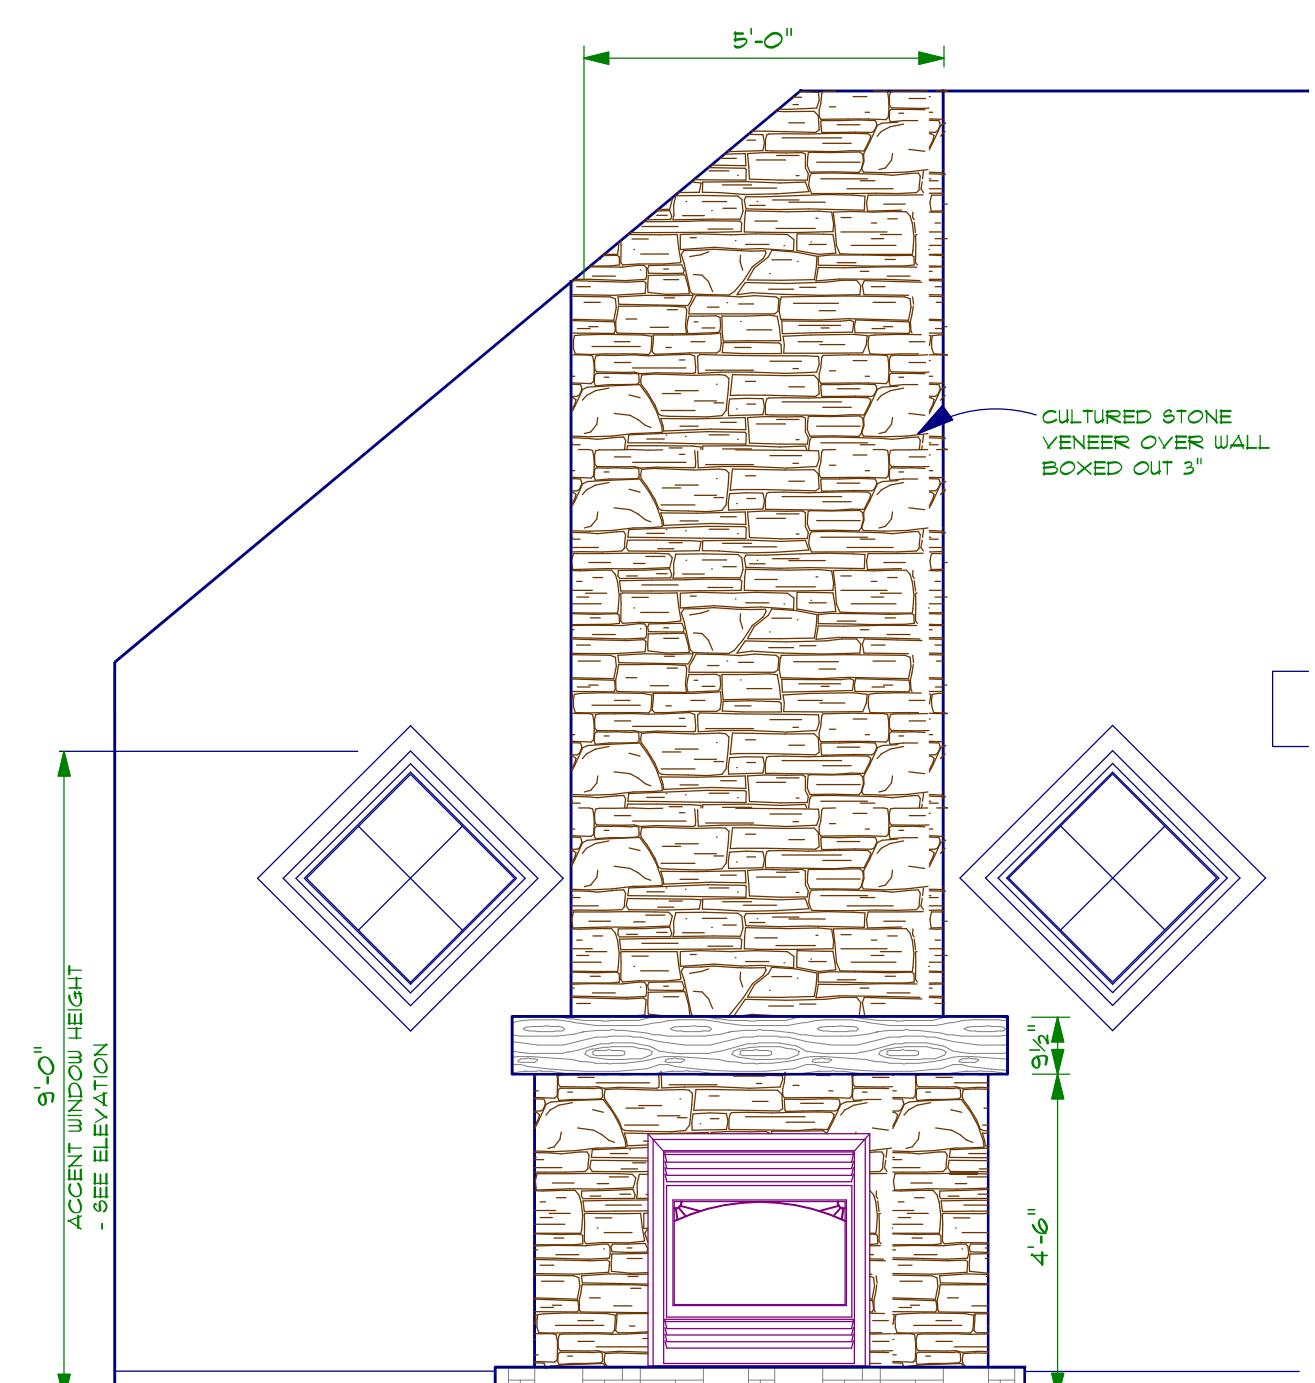

FIREPLACE ELEVATION - A
3/8" = 1'-0"



PACIFIC WEST HOME DESIGNS LTD.
105 COUCHAN BAY RD. COUCHAN BAY B.C.
P.O. BOX 5 COUCHAN BAY B.C. V0R 1N0

146 1720 www.pacificwestdesign.com
PHONE + FAX

TITLE: **lot 88 Mill Springs Phase 5**

MAIN FLOOR PLAN ELECTRICAL PLAN

SEAL:	DATE PLOTTED: APRIL 6 2006	JOB No:
	DESIGN: B.J.	DRAWN: B.J.
	SCALE: 1/4" = 1'-0"	SHEET No: 1 OF 5